

LIGHT SCHEDULE							
SYMBOL	LABEL	MANUFACTURER	CATALOG NUMBER	DESCRIPTION	MOUNT	MOUNT HT	COLOR
●	BL1	TARGETTI	MBB-41-40-36-L3-30-STD FINISH	PATH LIGHT BOLLARD	CONCRETE FOOTING	3.3'	BLACK
⊙	SL1	CURRENT	[SINGLE]RARI-160L-70-3K7-3-UNV-ASQU-STD FINISH-BC	STREET LIGHT	CONCRETE FOOTING	20'	BLACK
⊙	SL2	CURRENT	[DUAL]RARI-160L-70-3K7-4W-UNV-ASQU-STD FINISH	DOUBLE HEADED STREET LIGHT	CONCRETE FOOTING	20'	BLACK
⊙	SL3	CURRENT	[SINGLE]RARI-160L-70-3K7-4W-UNV-ASQU-STD FINISH	STREET LIGHT	CONCRETE FOOTING	20'	BLACK
■	WL1a	CURRENT	RWL2-160L-50-3K7-4W-UNV-STD FINISH	WALL MOUNTED LIGHT	WALL MOUNTED	18'	BLACK
■	WL1c	CURRENT	LN2-48L-15-3K7-4W-UNV-STD FINISH	WALL MOUNTED LIGHT	WALL MOUNTED	10'	BLACK
○	WL3	CURRENT	LTR-6RD-H-SL06L-DM1-LTR-6RD-T-SL30K8WDS	BUILDING MOUNTED LIGHT	BUILDING MOUNTED	9'	BLACK

CONTACT: ILLUMINATE, 617-947-8996, STEVE PRUDHOMME  
 1. SUBMIT CUT SHEETS FOR LANDSCAPE ARCHITECT APPROVAL  
 2. \*MH\* = MOUNTING HEIGHT IN FEET


Luminaire Schedule				
Qty	Label	Arr. Watts	Arrangement	Description
10	BL1	27	SINGLE	0.900 MBB41 36L330FE
6	SL1	68.4	SINGLE	0.900 RAR-1-160L-70-3K7-3-BC
3	SL2	136.8	BACK-BACK	0.900 RAR1-160L-70-3K7-4W-U
5	SL3	68.4	SINGLE	0.900 RAR1-160L-70-3K7-4W-U
4	WL1a	54	SINGLE	0.900 RWL2-160L-50-3K7-4-U
4	WL1c	15	SINGLE	0.900 LN2-48L-15-3K7-4W-UNV
3	WL3	7.8	SINGLE	0.900 LTR-6RD-H-SL06L-DM1-LTR-6RD-T-SL35K8WDS

Calculation Summary						
Label	Units	Avg	Max	Min	Avg/Min	Max/Min
Site	Fc	0.57	8.6	0.0	N.A.	N.A.

MDLA

MICHAEL D'ANGELO  
 LANDSCAPE ARCHITECTURE LLC  
 119 GRISWOLD STREET  
 SUITE 309  
 GASTONBURY, CT 06033  
 T. 203.592.4788  
 www.m-d-a.com

HORIZON VIEW  
 MONTVILLE, CT

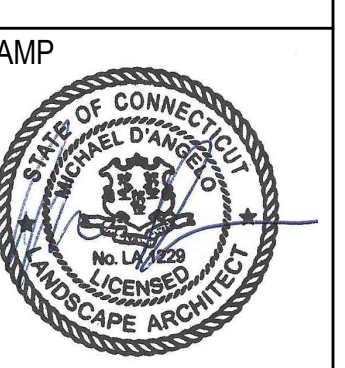

REV. NO.	DATE	DESCRIPTION
1	9/25/24	IRLAND WETLANDS SUBMISSION
2	12/2/24	RESPONSE TO FIRE MARSHALL COMMENTS

SIGNATURE BLOCK

---



---



---



---



---



---


NOT FOR CONSTRUCTION



2 LANDSCAPE LIGHTING PHOTOMETRICS PLAN  
 SCALE: 1" = 20'-0"

LANDSCAPE LIGHTING PHOTOMETRICS PLAN


DRAWN: MR. CB  
 CHECKED: MR.  
 SCALE: AS NOTED  
 DATE: 09/25/24  
**L201**

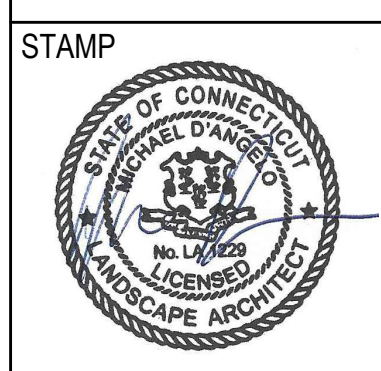


REV. NO.	DATE	DESCRIPTION
	9/25/24	INLAND WETLANDS SUBMISSION
	12/2/24	RESPONSE TO FIRE MARSHALL COMMENTS

LANDSCAPE DETAILS


DRAWN: MR. CB	L300
CHECKED: MR	
SCALE: AS NOTED	
DATE: 09/25/24	
SHEET 4 OF 6	

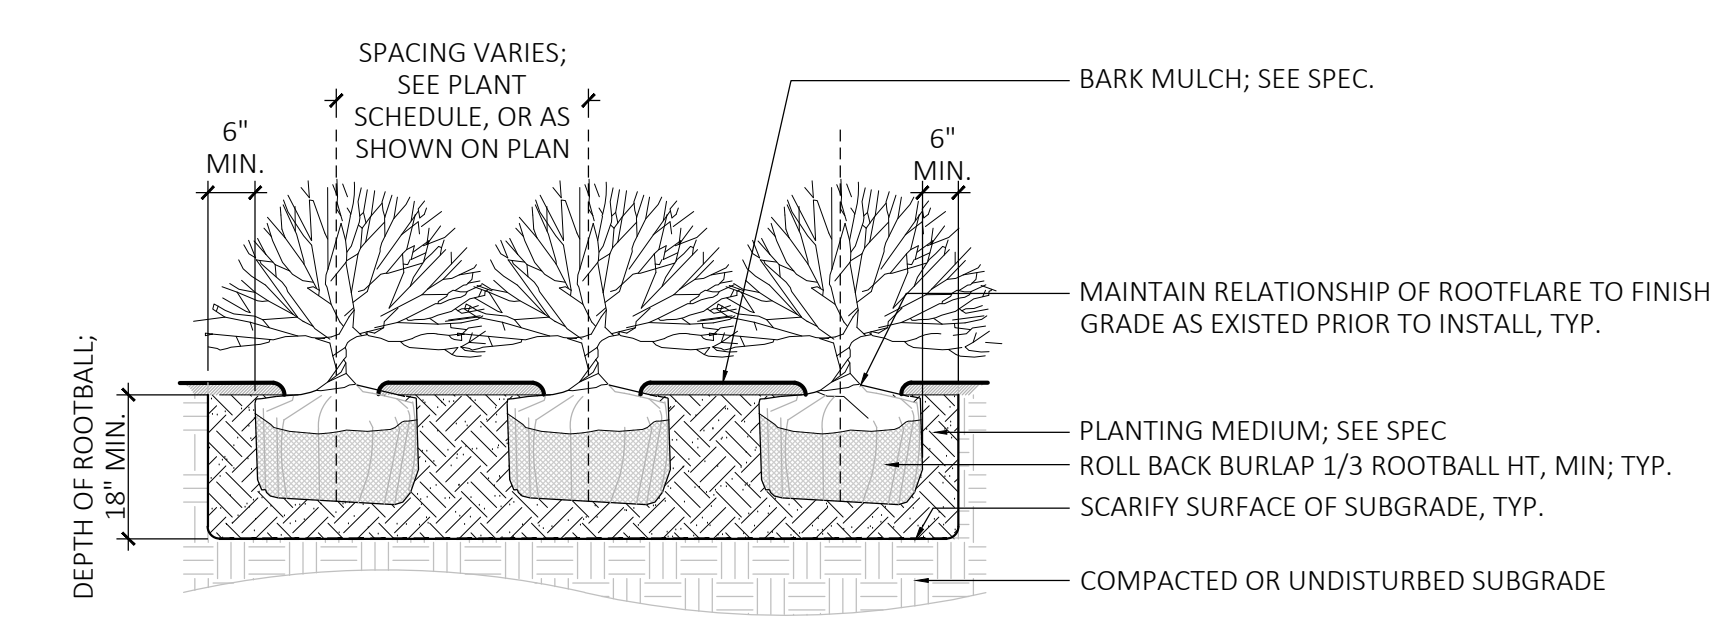


3 SHRUB PLANTING  
SCALE: 3/8" = 1'-0"

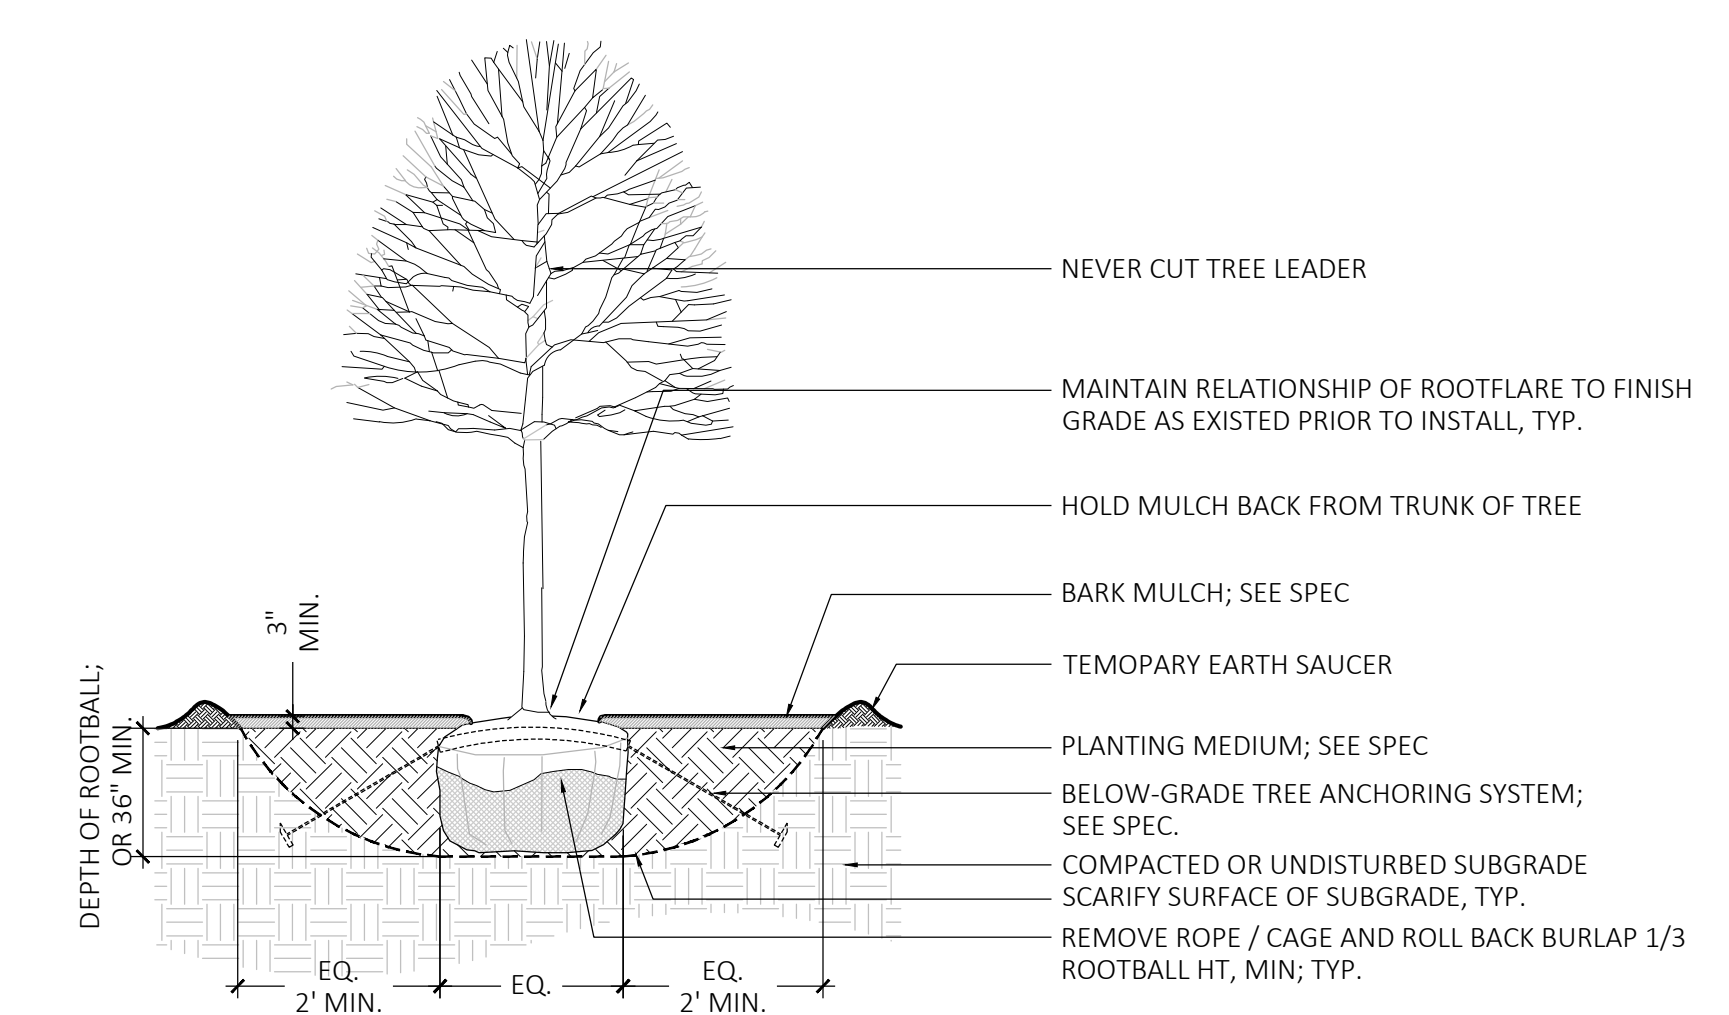


4 DECIDUOUS TREE PLANTING  
SCALE: 3/8" = 1'-0"

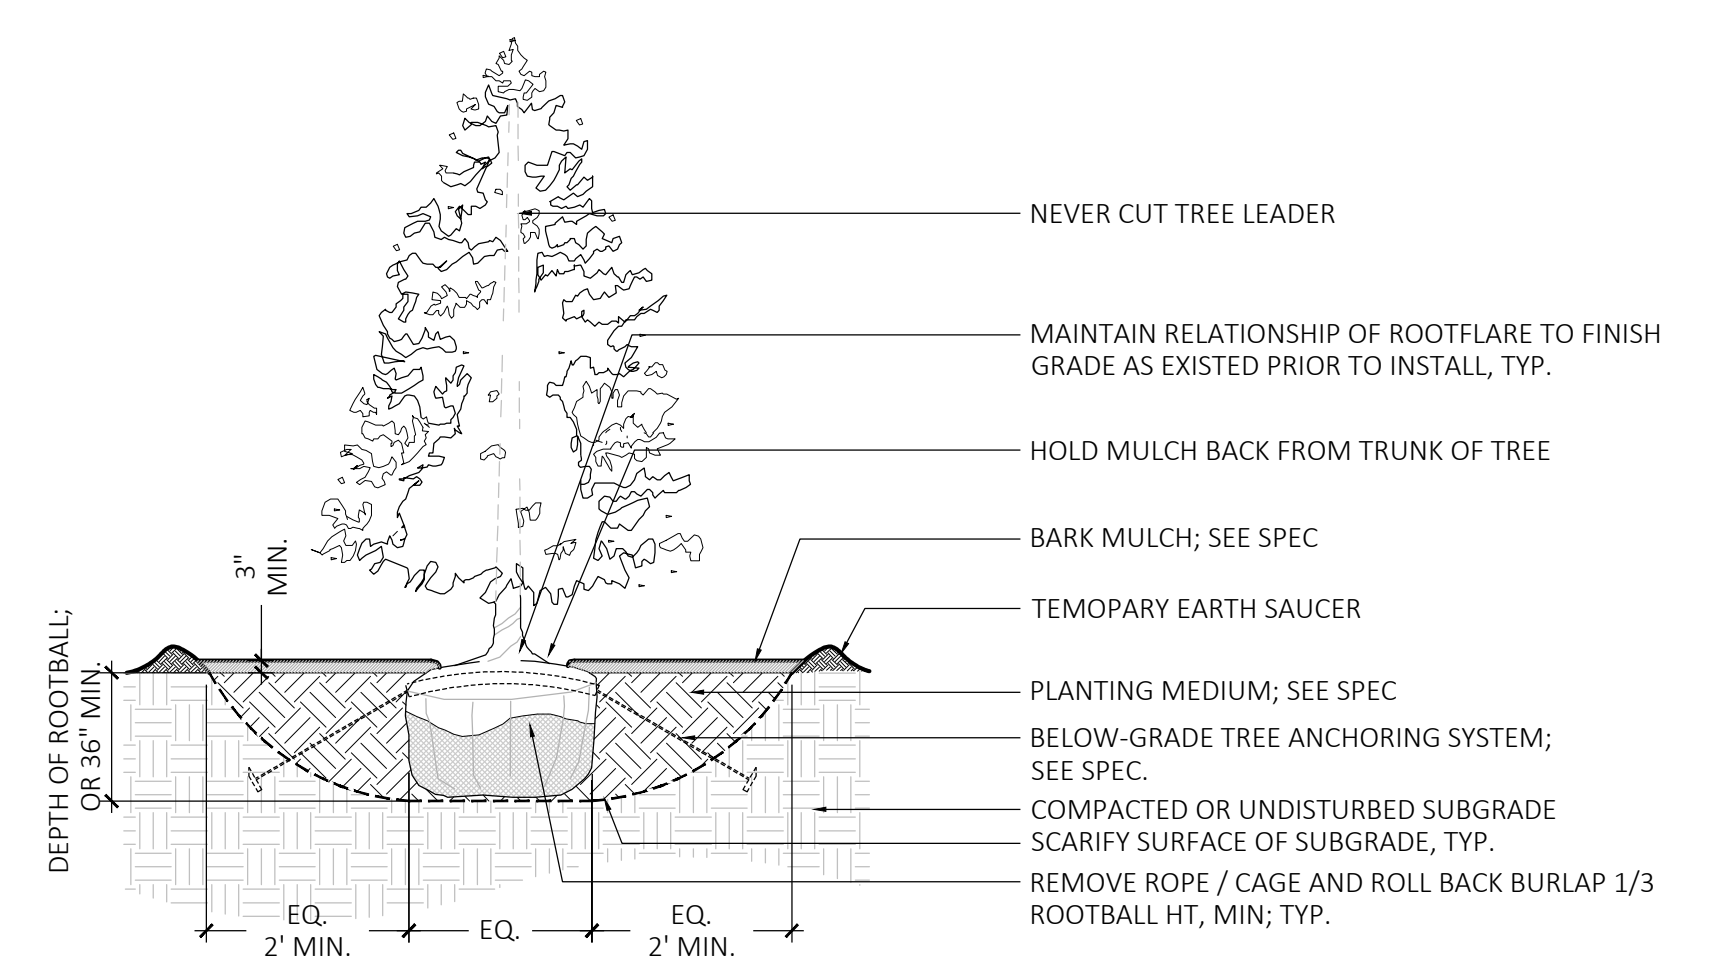

5 EVERGREEN TREE PLANTING  
SCALE: 3/8" = 1'-0"

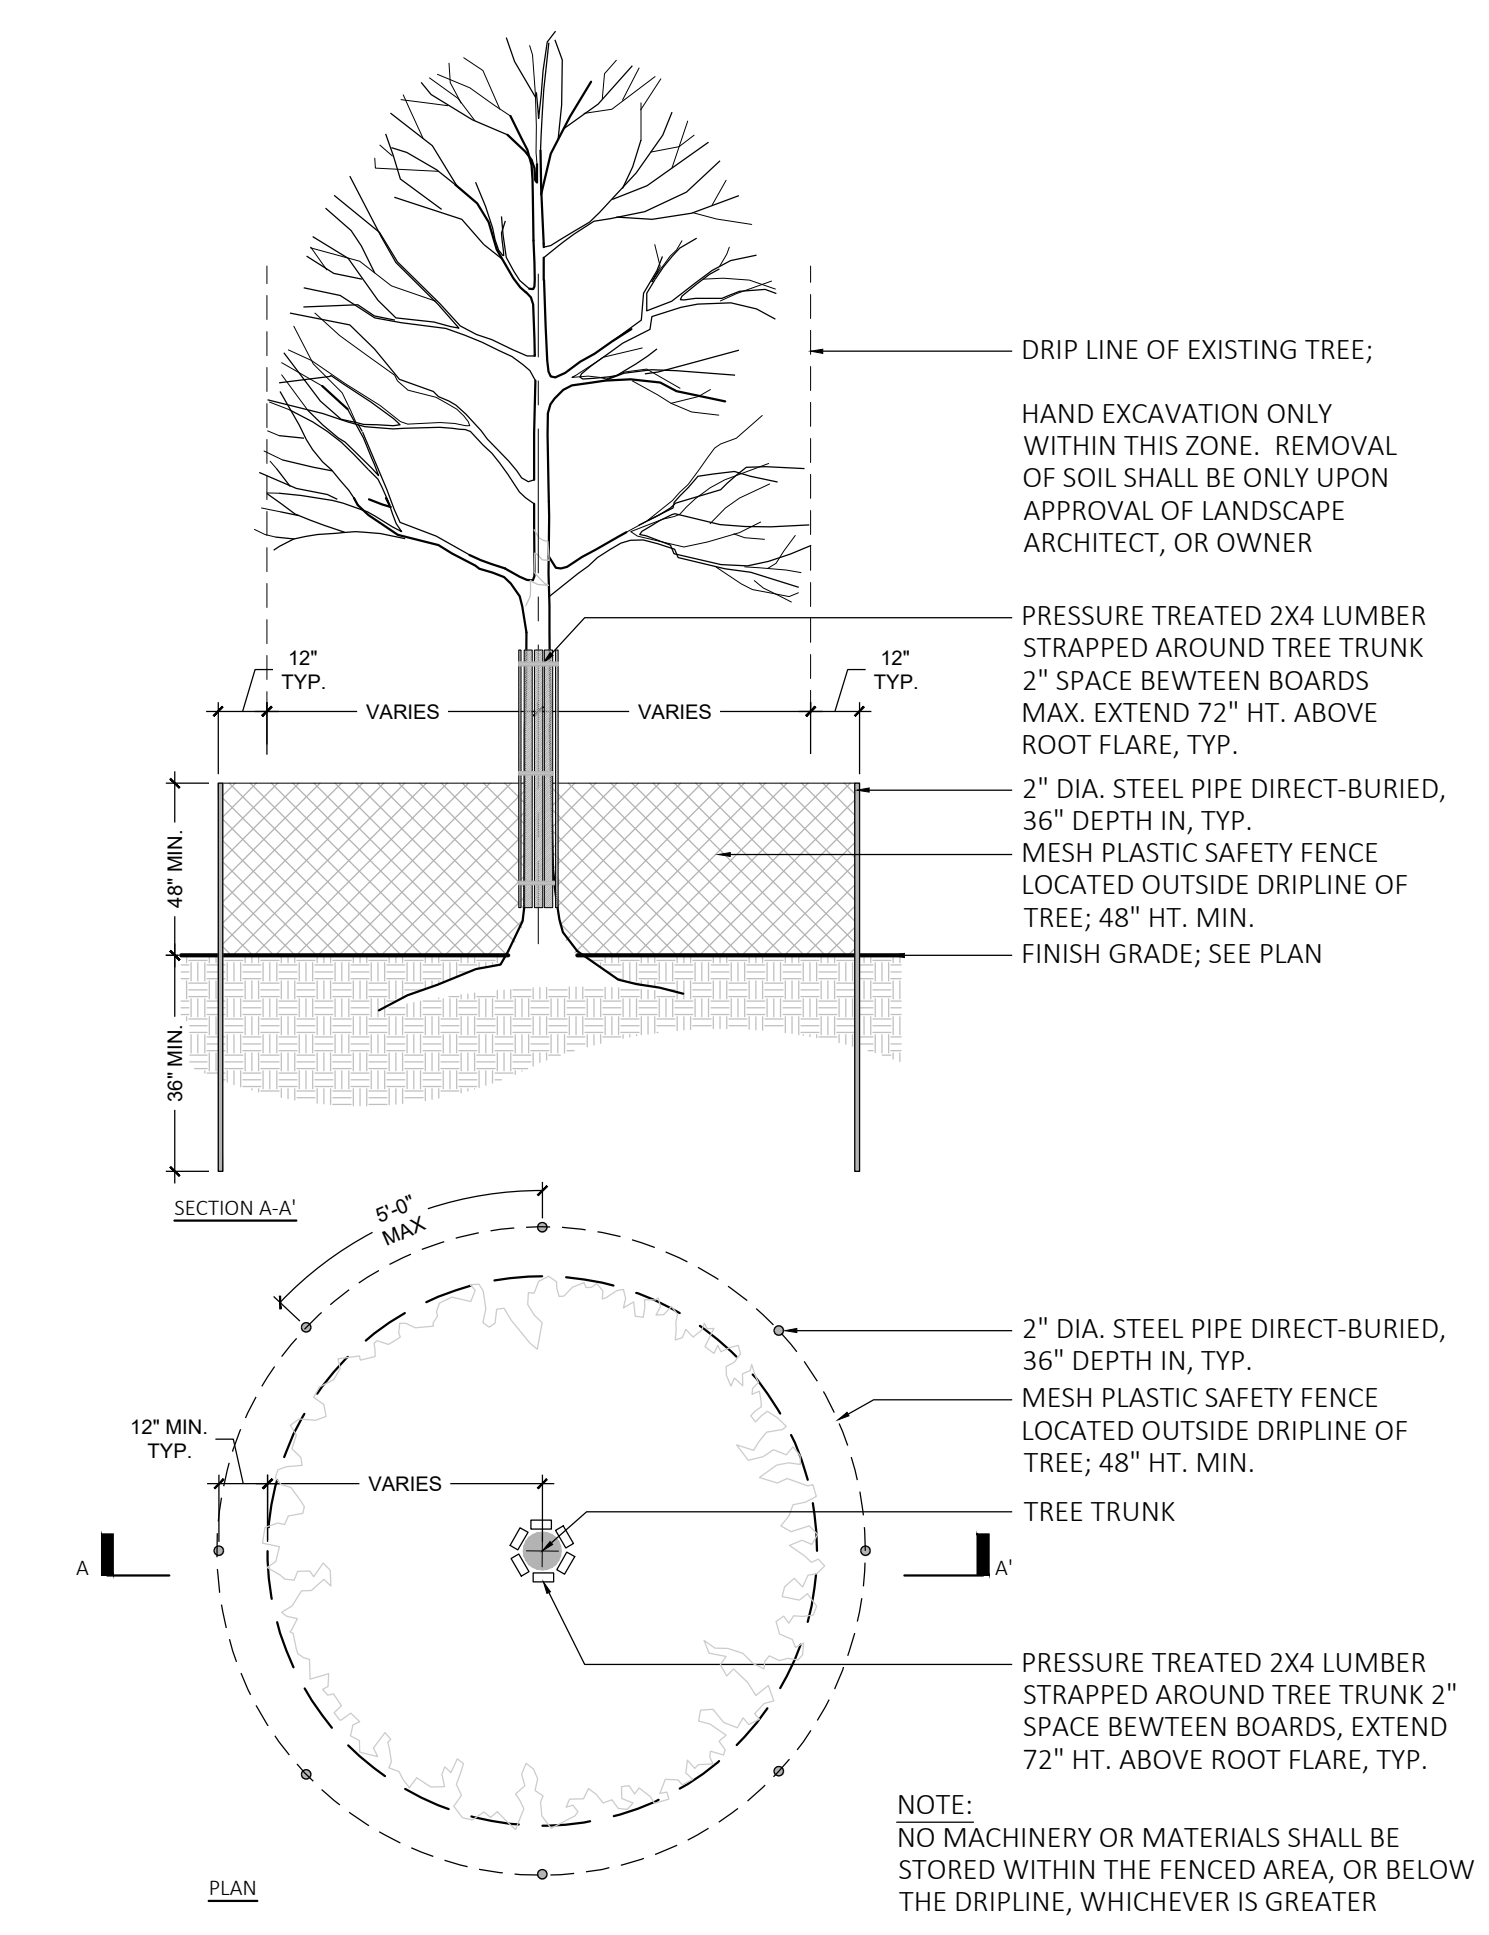

1 TREE PROTECTION FENCING  
SCALE: 3/8" = 1'-0"

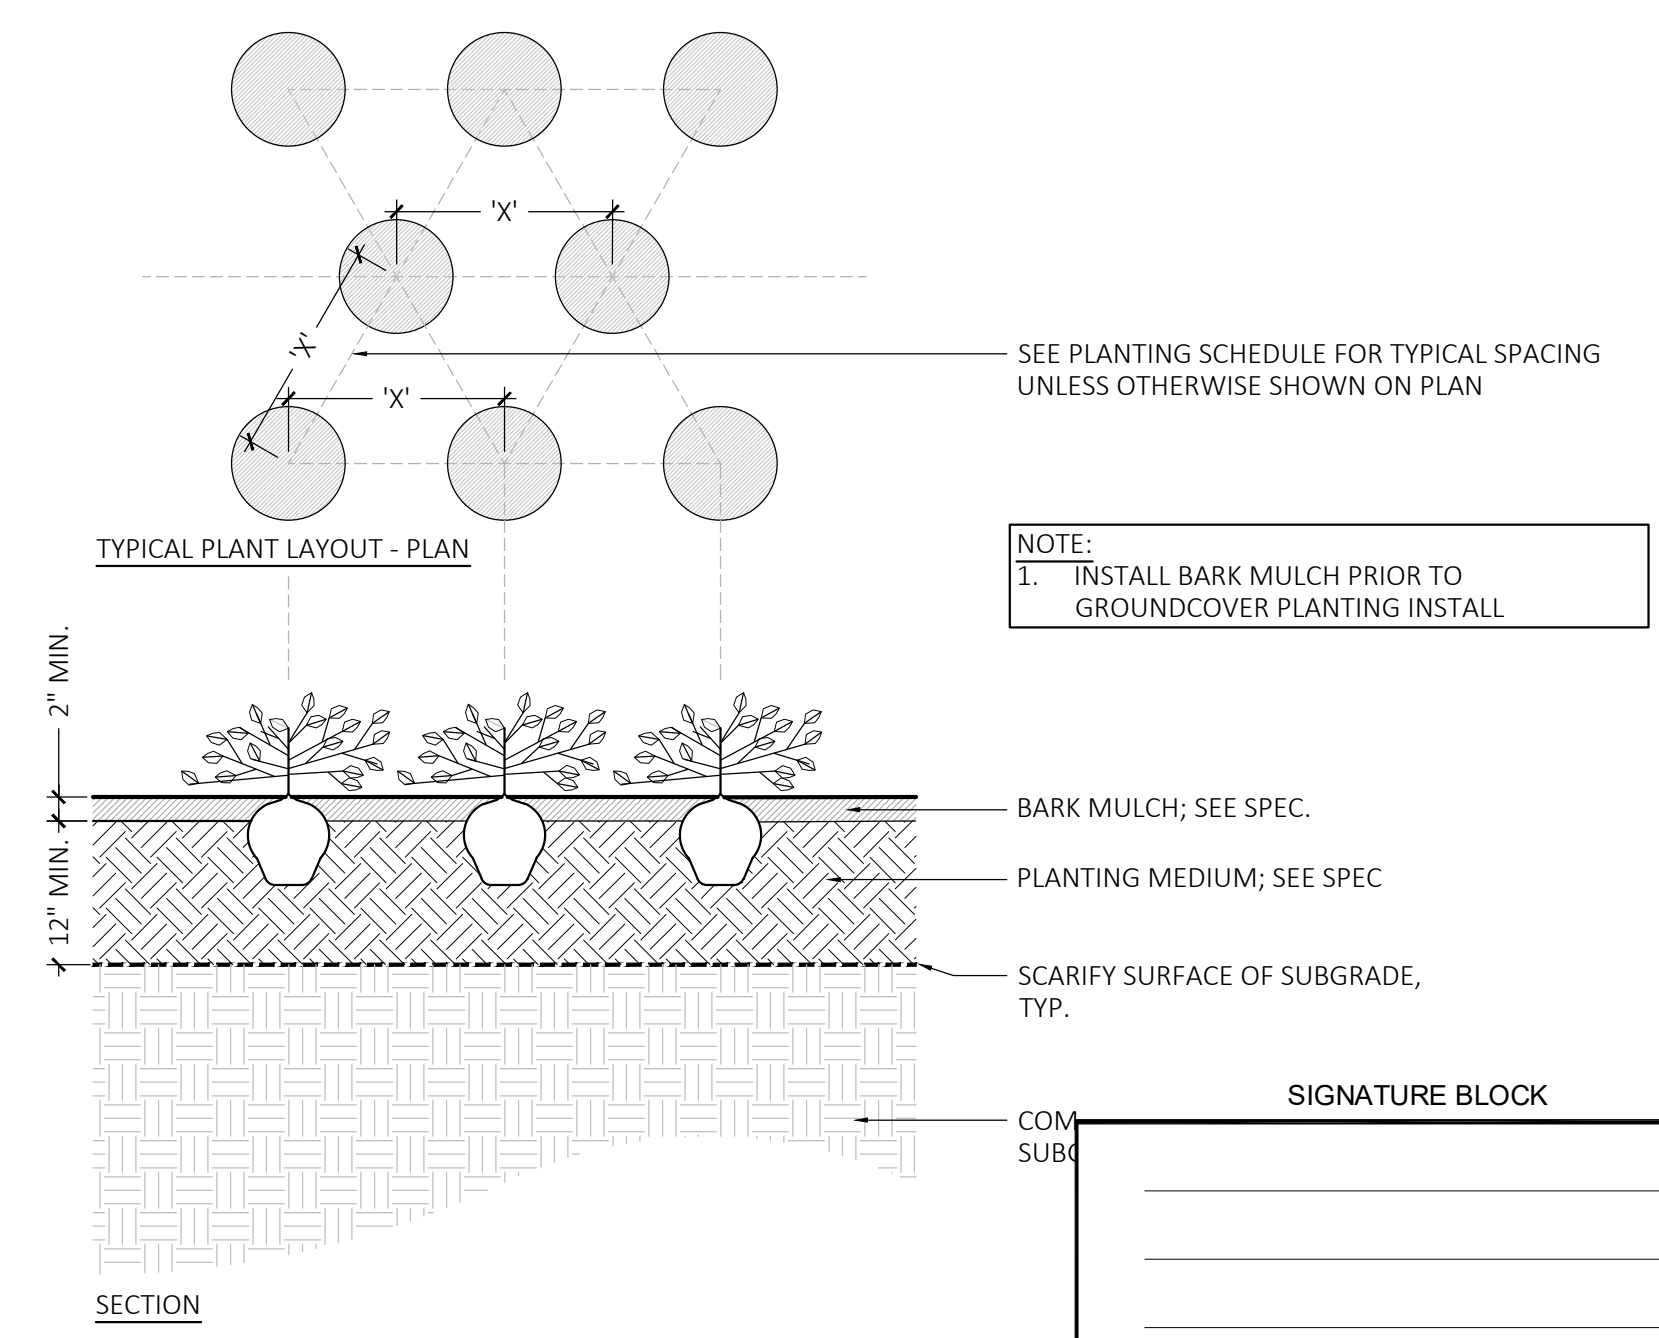

2 GROUNDCOVER PLANTING  
SCALE: 3/4" = 1'-0"

SIGNATURE BLOCK

\_\_\_\_\_

\_\_\_\_\_

\_\_\_\_\_

\_\_\_\_\_

\_\_\_\_\_

\_\_\_\_\_