



Y:\PROJECTS\72 - 179 Gallivan Lane\Drawings\GSD-72 - 179 Gallivan Lane Site Plans v3.dwg, 8/12/2025 11:03:23 AM



		 <b>Green Site Design LLC</b> CONSULTING CIVIL ENGINEERS	
		317 Main Street Norwich, CT 06360 (860) 886-1966 Fax (860) 886-9165	
No.	DATE	REVISION	
		<b>FLUID LINE PRODUCTS LLC.</b>	
		<b>179 GALLIVAN LANE</b> <b>PROPOSED INDUSTRIAL BUILDING</b>	
		<b>EXISTING DRAINAGE CONDITIONS</b>	
		Project No.	GSD-72
		Proj. Engineer	E.M.B.
		Date:	NOV. 2024
		Sheet No.	<b>D-1</b>

Y:\PROJECTS\72 - 179 Gallivan Lane\Drawings\GSD-72 - 179 Gallivan Lane Site Plans v3.dwg, 8/12/2025 11:04:40 AM

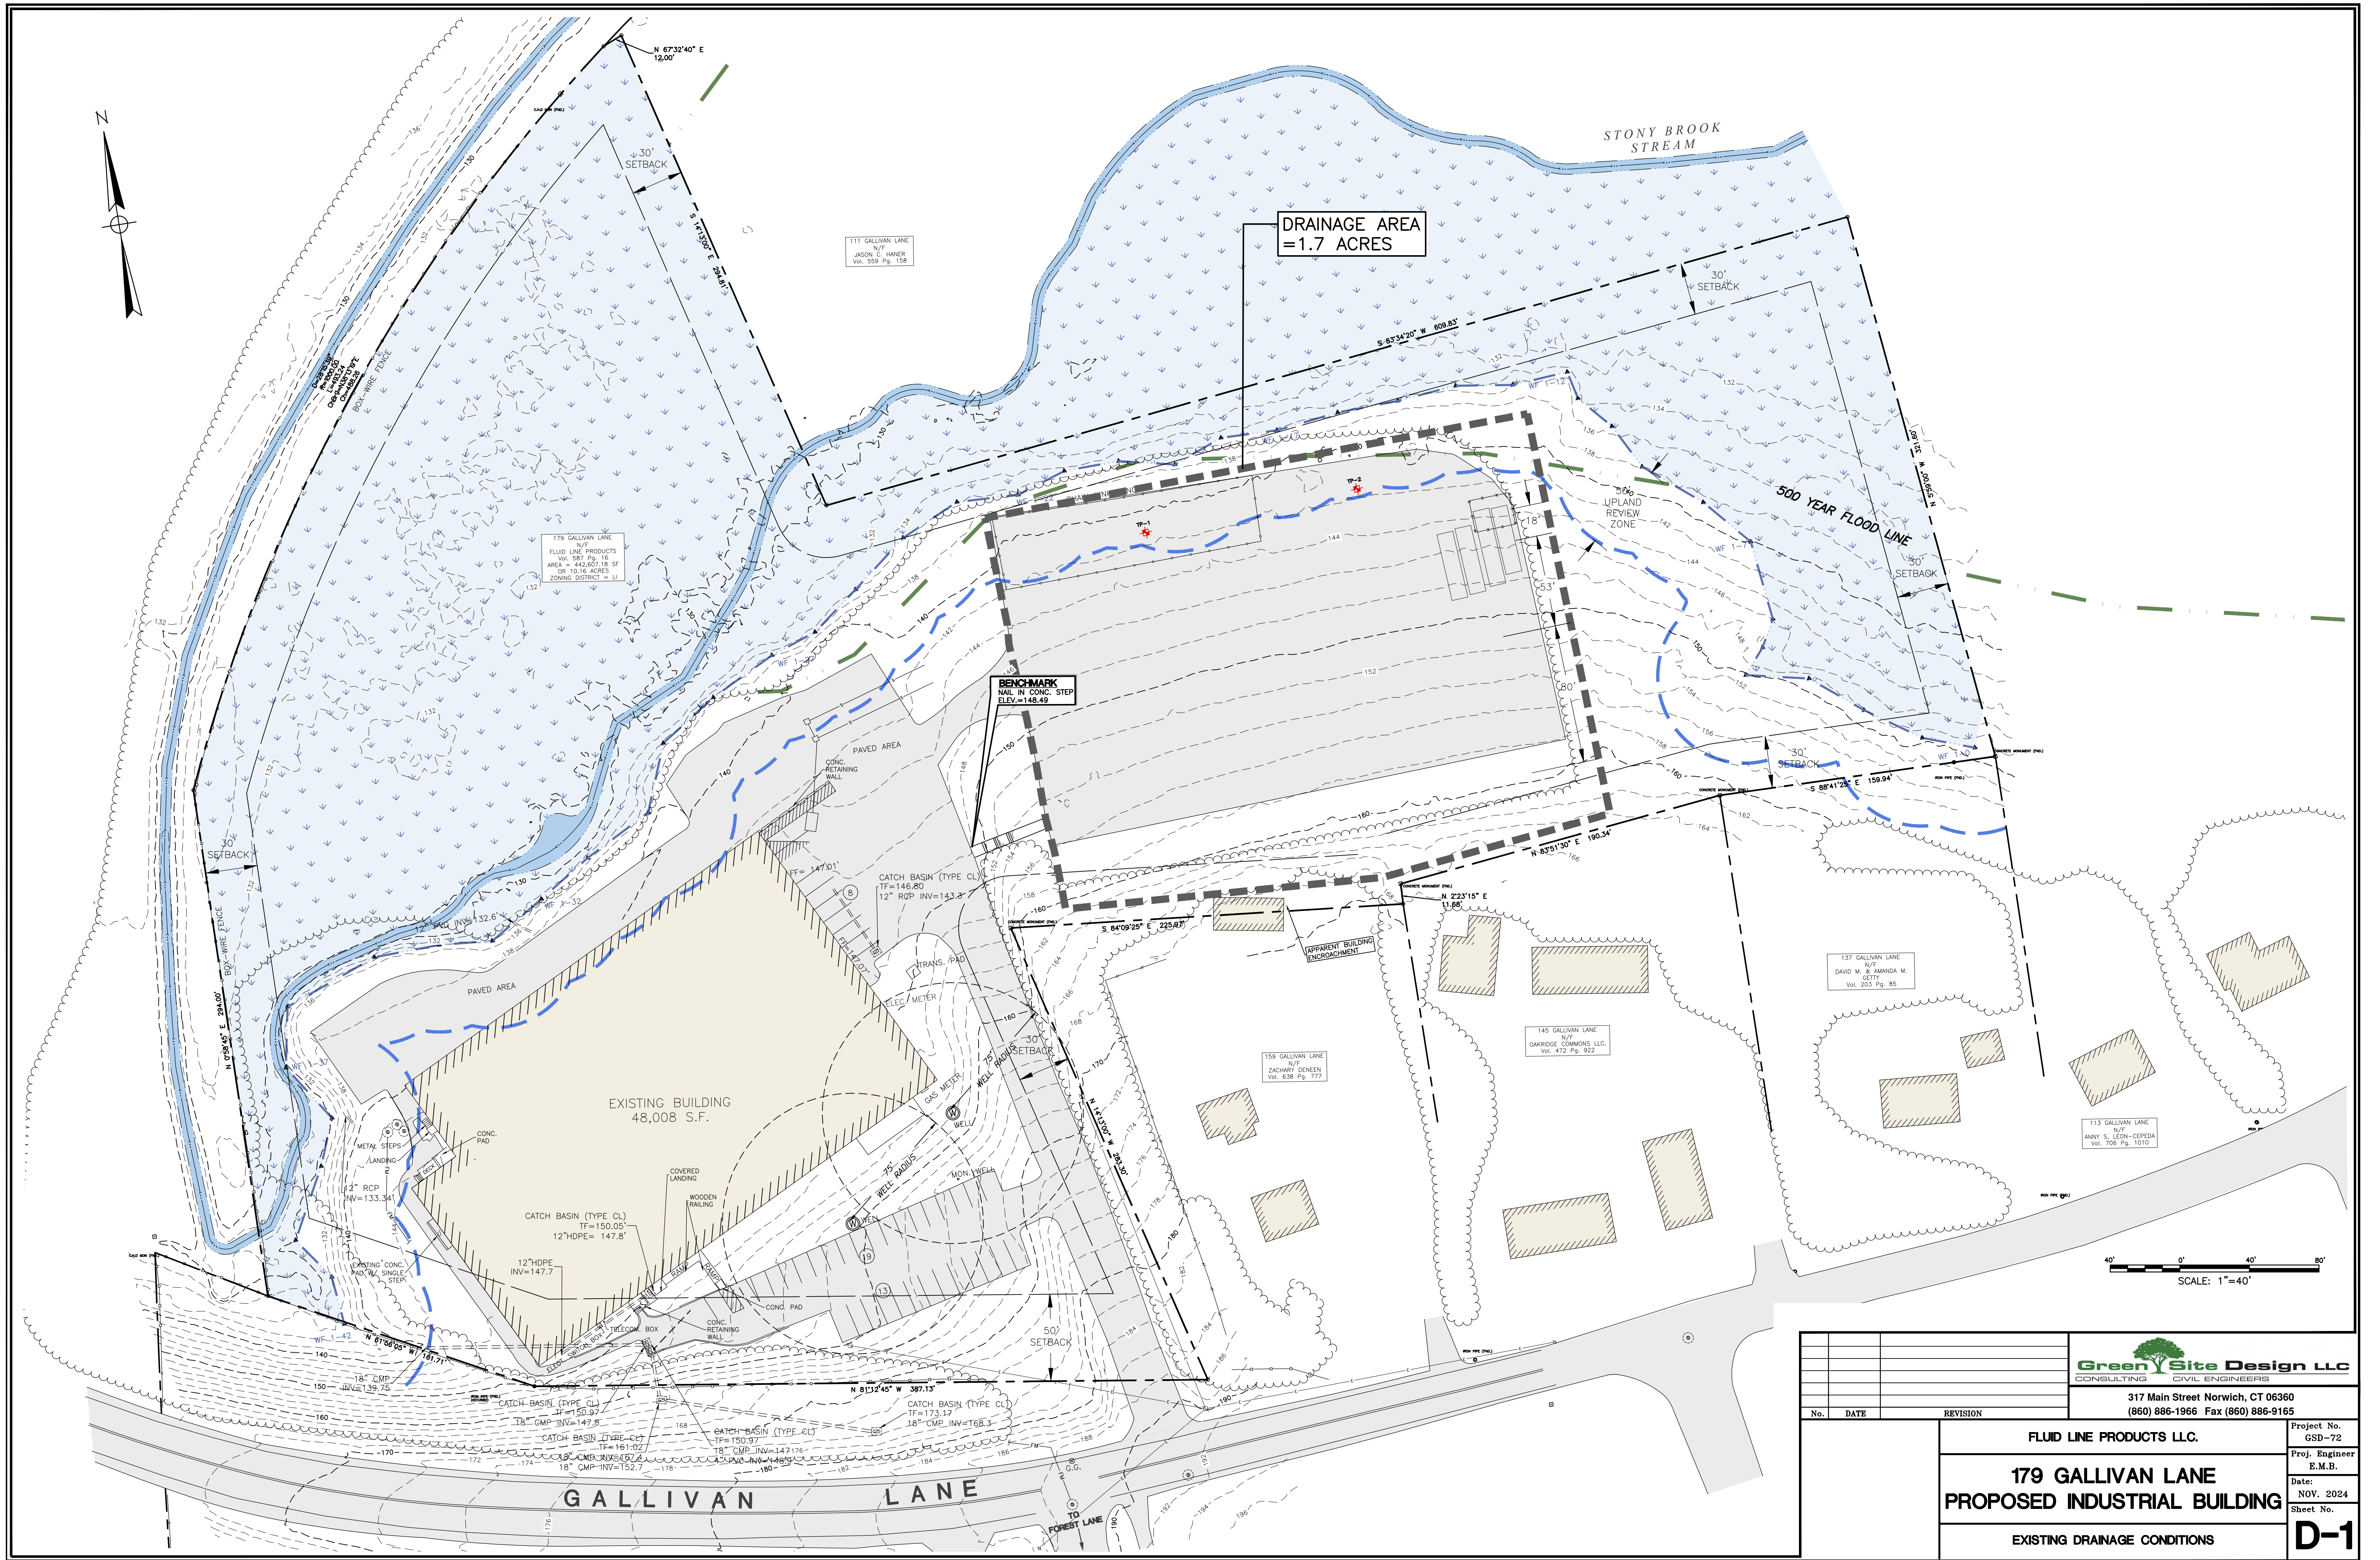